


Bore Well with Hand Pump

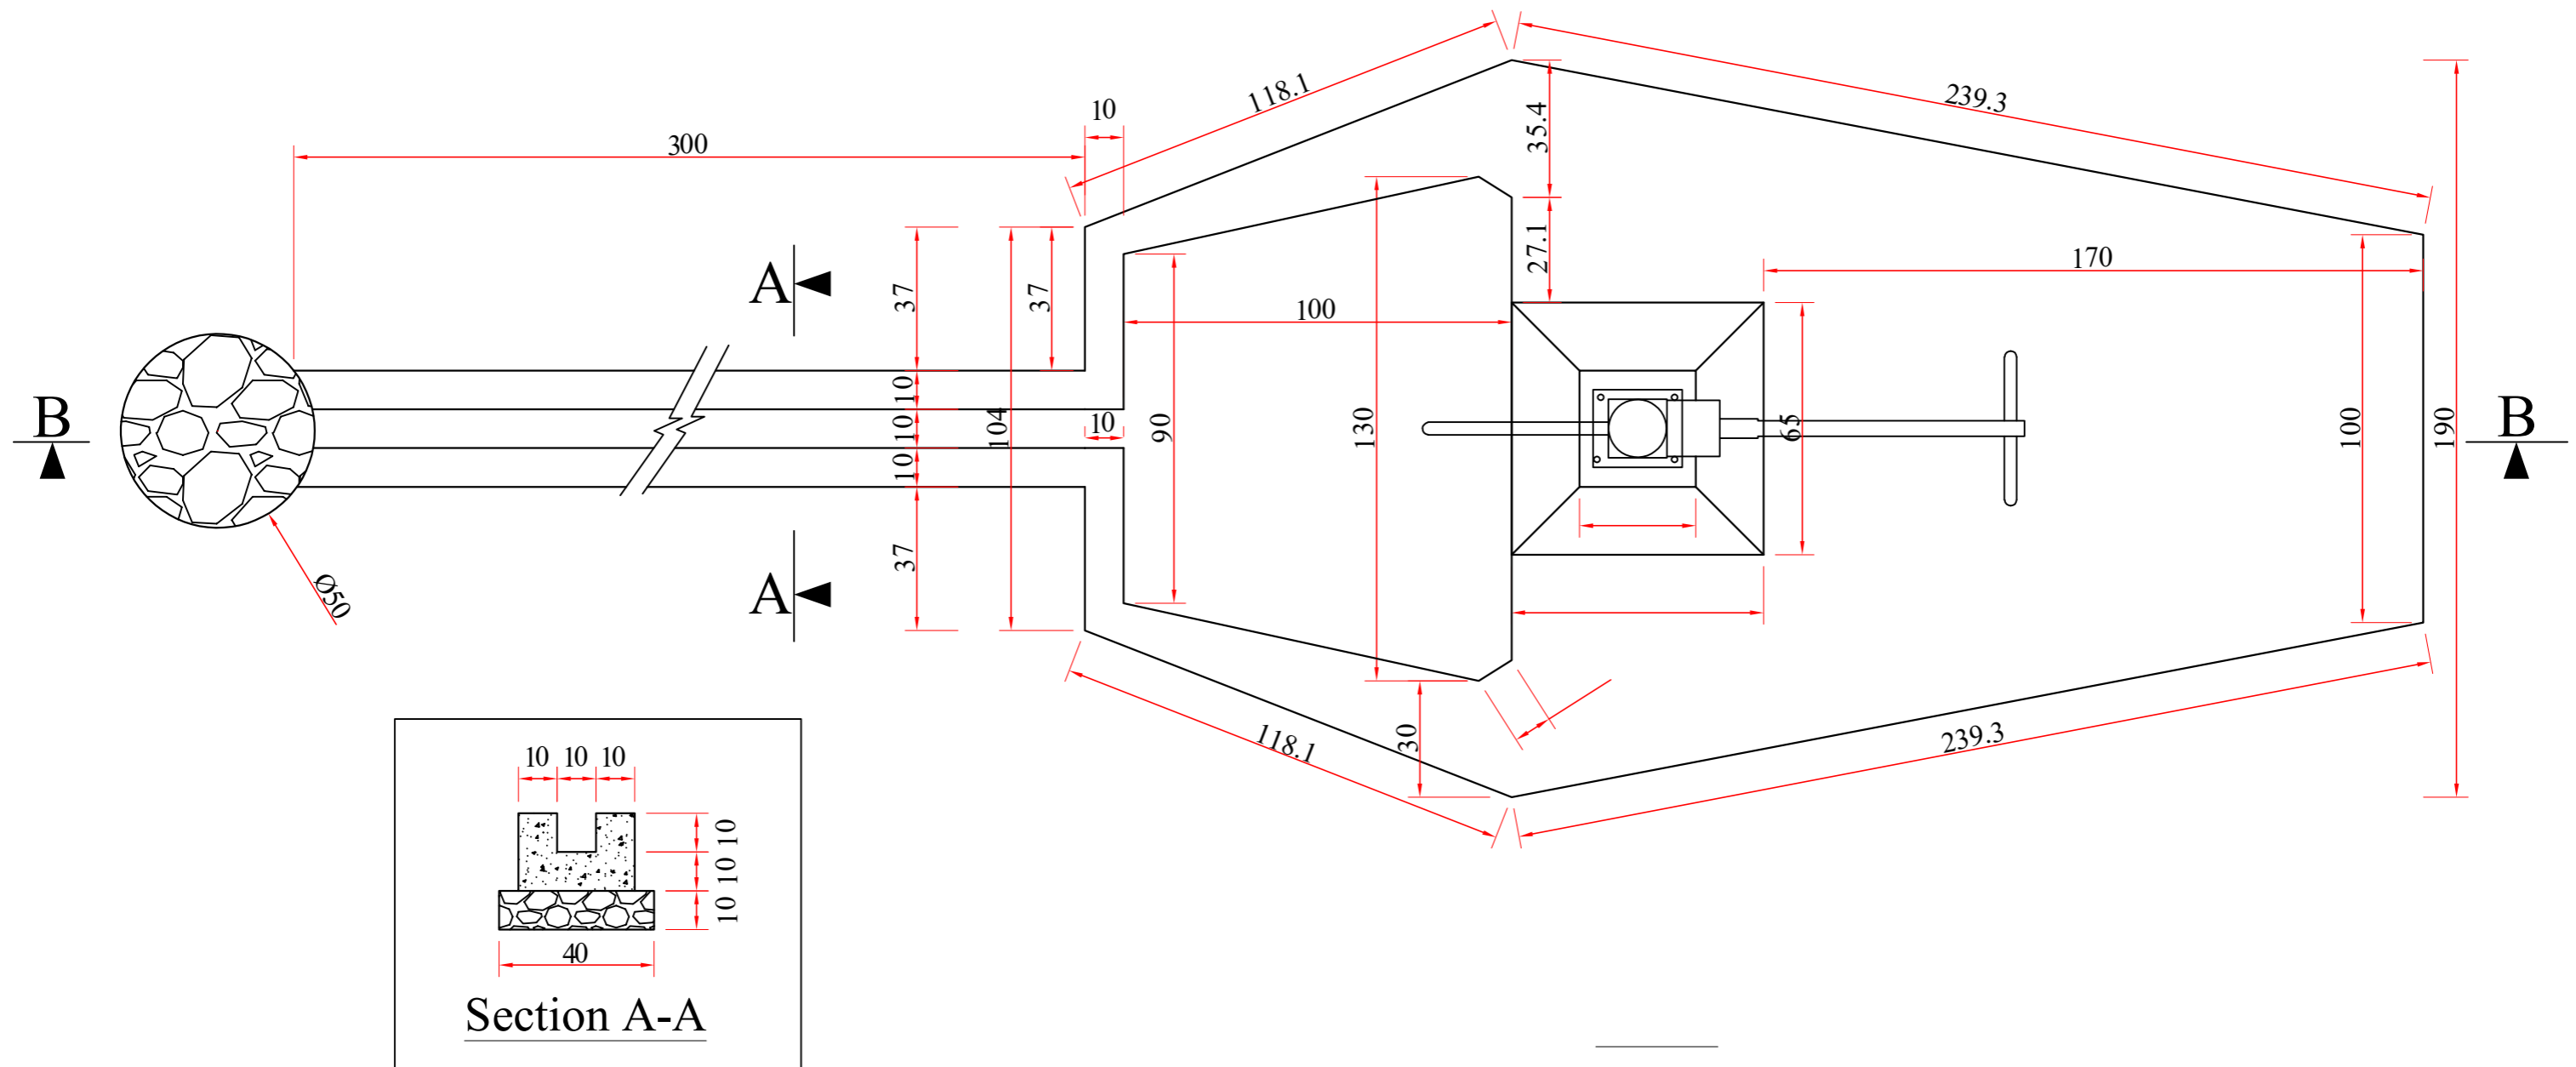


Note:


- 1All dimensions are in cm unless otherwise stated.
- 2All PCC works should be with 1:2:4mortar unless otherwise stated.
- 3Curing must be continued upto 07days.
- 4Clear and Clean water must be used every where.

	SURVEYED BY	ORCD	CHECKED BY	ORCD	SCALE		PROVINCE	BAGHLAN	PROJECT NAME <i>Water Supply Project</i>	SHEET NO.	<div>1</div>
	DESIGNED BY	ORCD	REVIEWED BY		DATE		DISTRICT	Diffrent Districts			<div></div>
	DRAWN BY		APPROVED BY		DRAWING NO.	01	VILLAGE	Different Villges	DRAWING TITLE Bore Well with Hand Pump		<div>WS</div>


Front Elevation

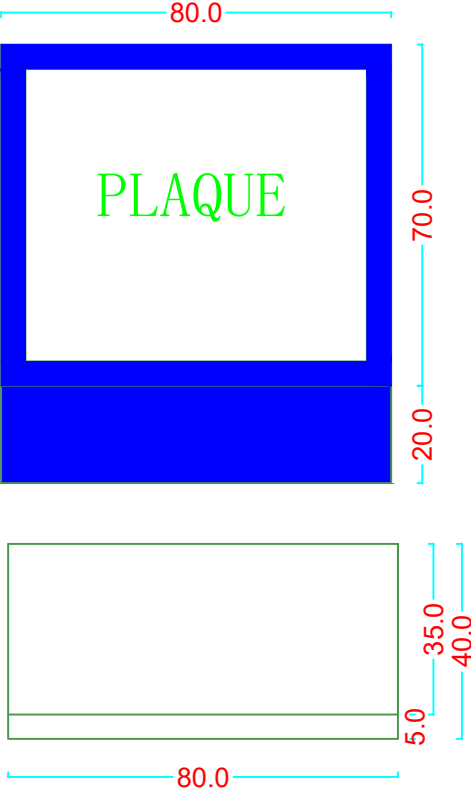



Section(A-A)

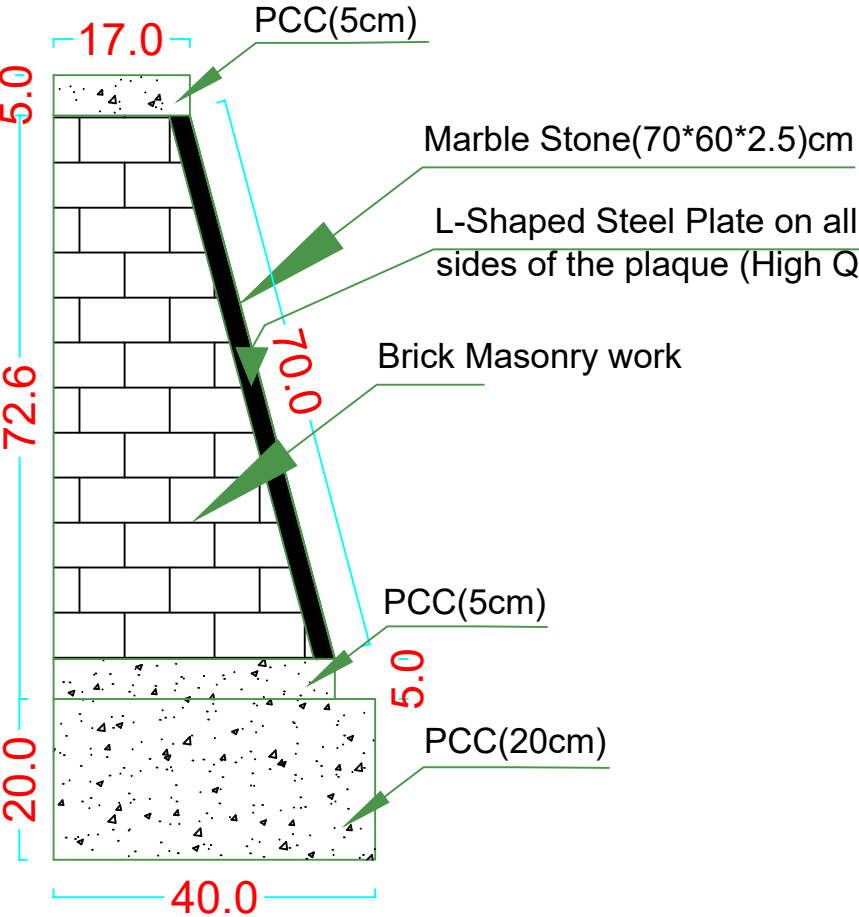

Side Elevation

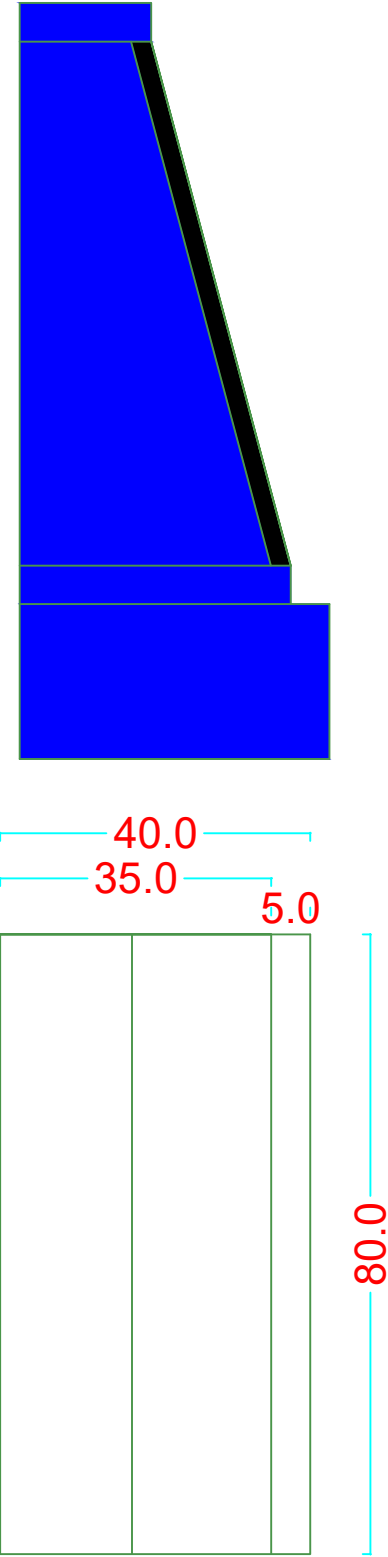

Isometric

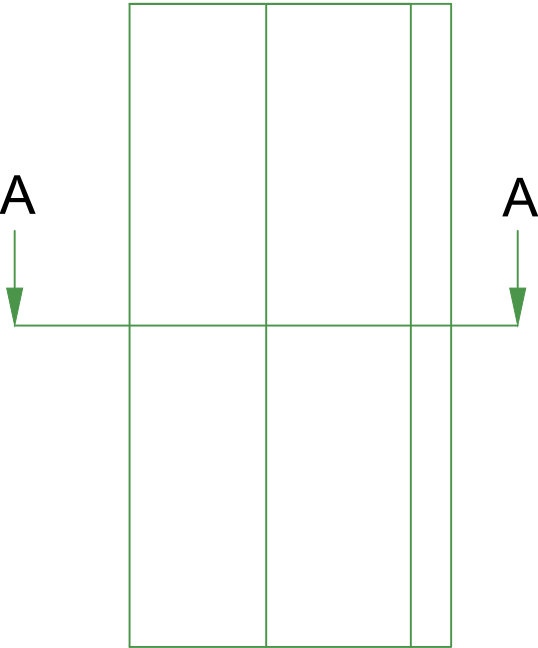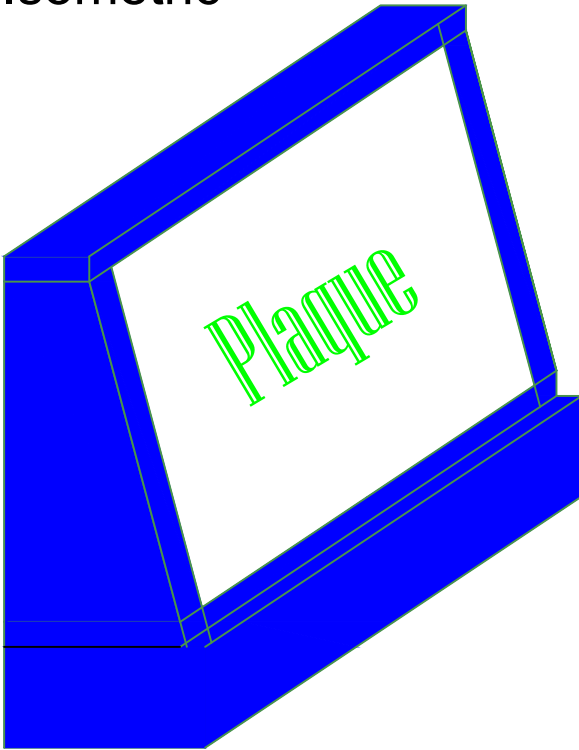

	No	Date	Revision		Organization for Research and Community Development Global (ORCDG)	Scale	As Shown	Sheet No. 01 01	Province		
	1			Drawn by		Date			District		
	2			Reviewed by		Drawing No.			Village / CDC		
	3			Approved by							